


PLANT PROPERTY INFORMATION
TAKEN FROM:

SITE PLAN
CHEVROLET MOTOR DIVISION
GENERAL MOTORS CORPORATION
N-E CORNER ROUTE 37 EAST &
PENN CENTRAL RAILROAD
TOWN OF MASSENA NEW YORK
DRAWN BY DAVE FAYETTE
1971
UPDATED 1974

DRAWN BY WILL LAMICA
10 JUNE 2005

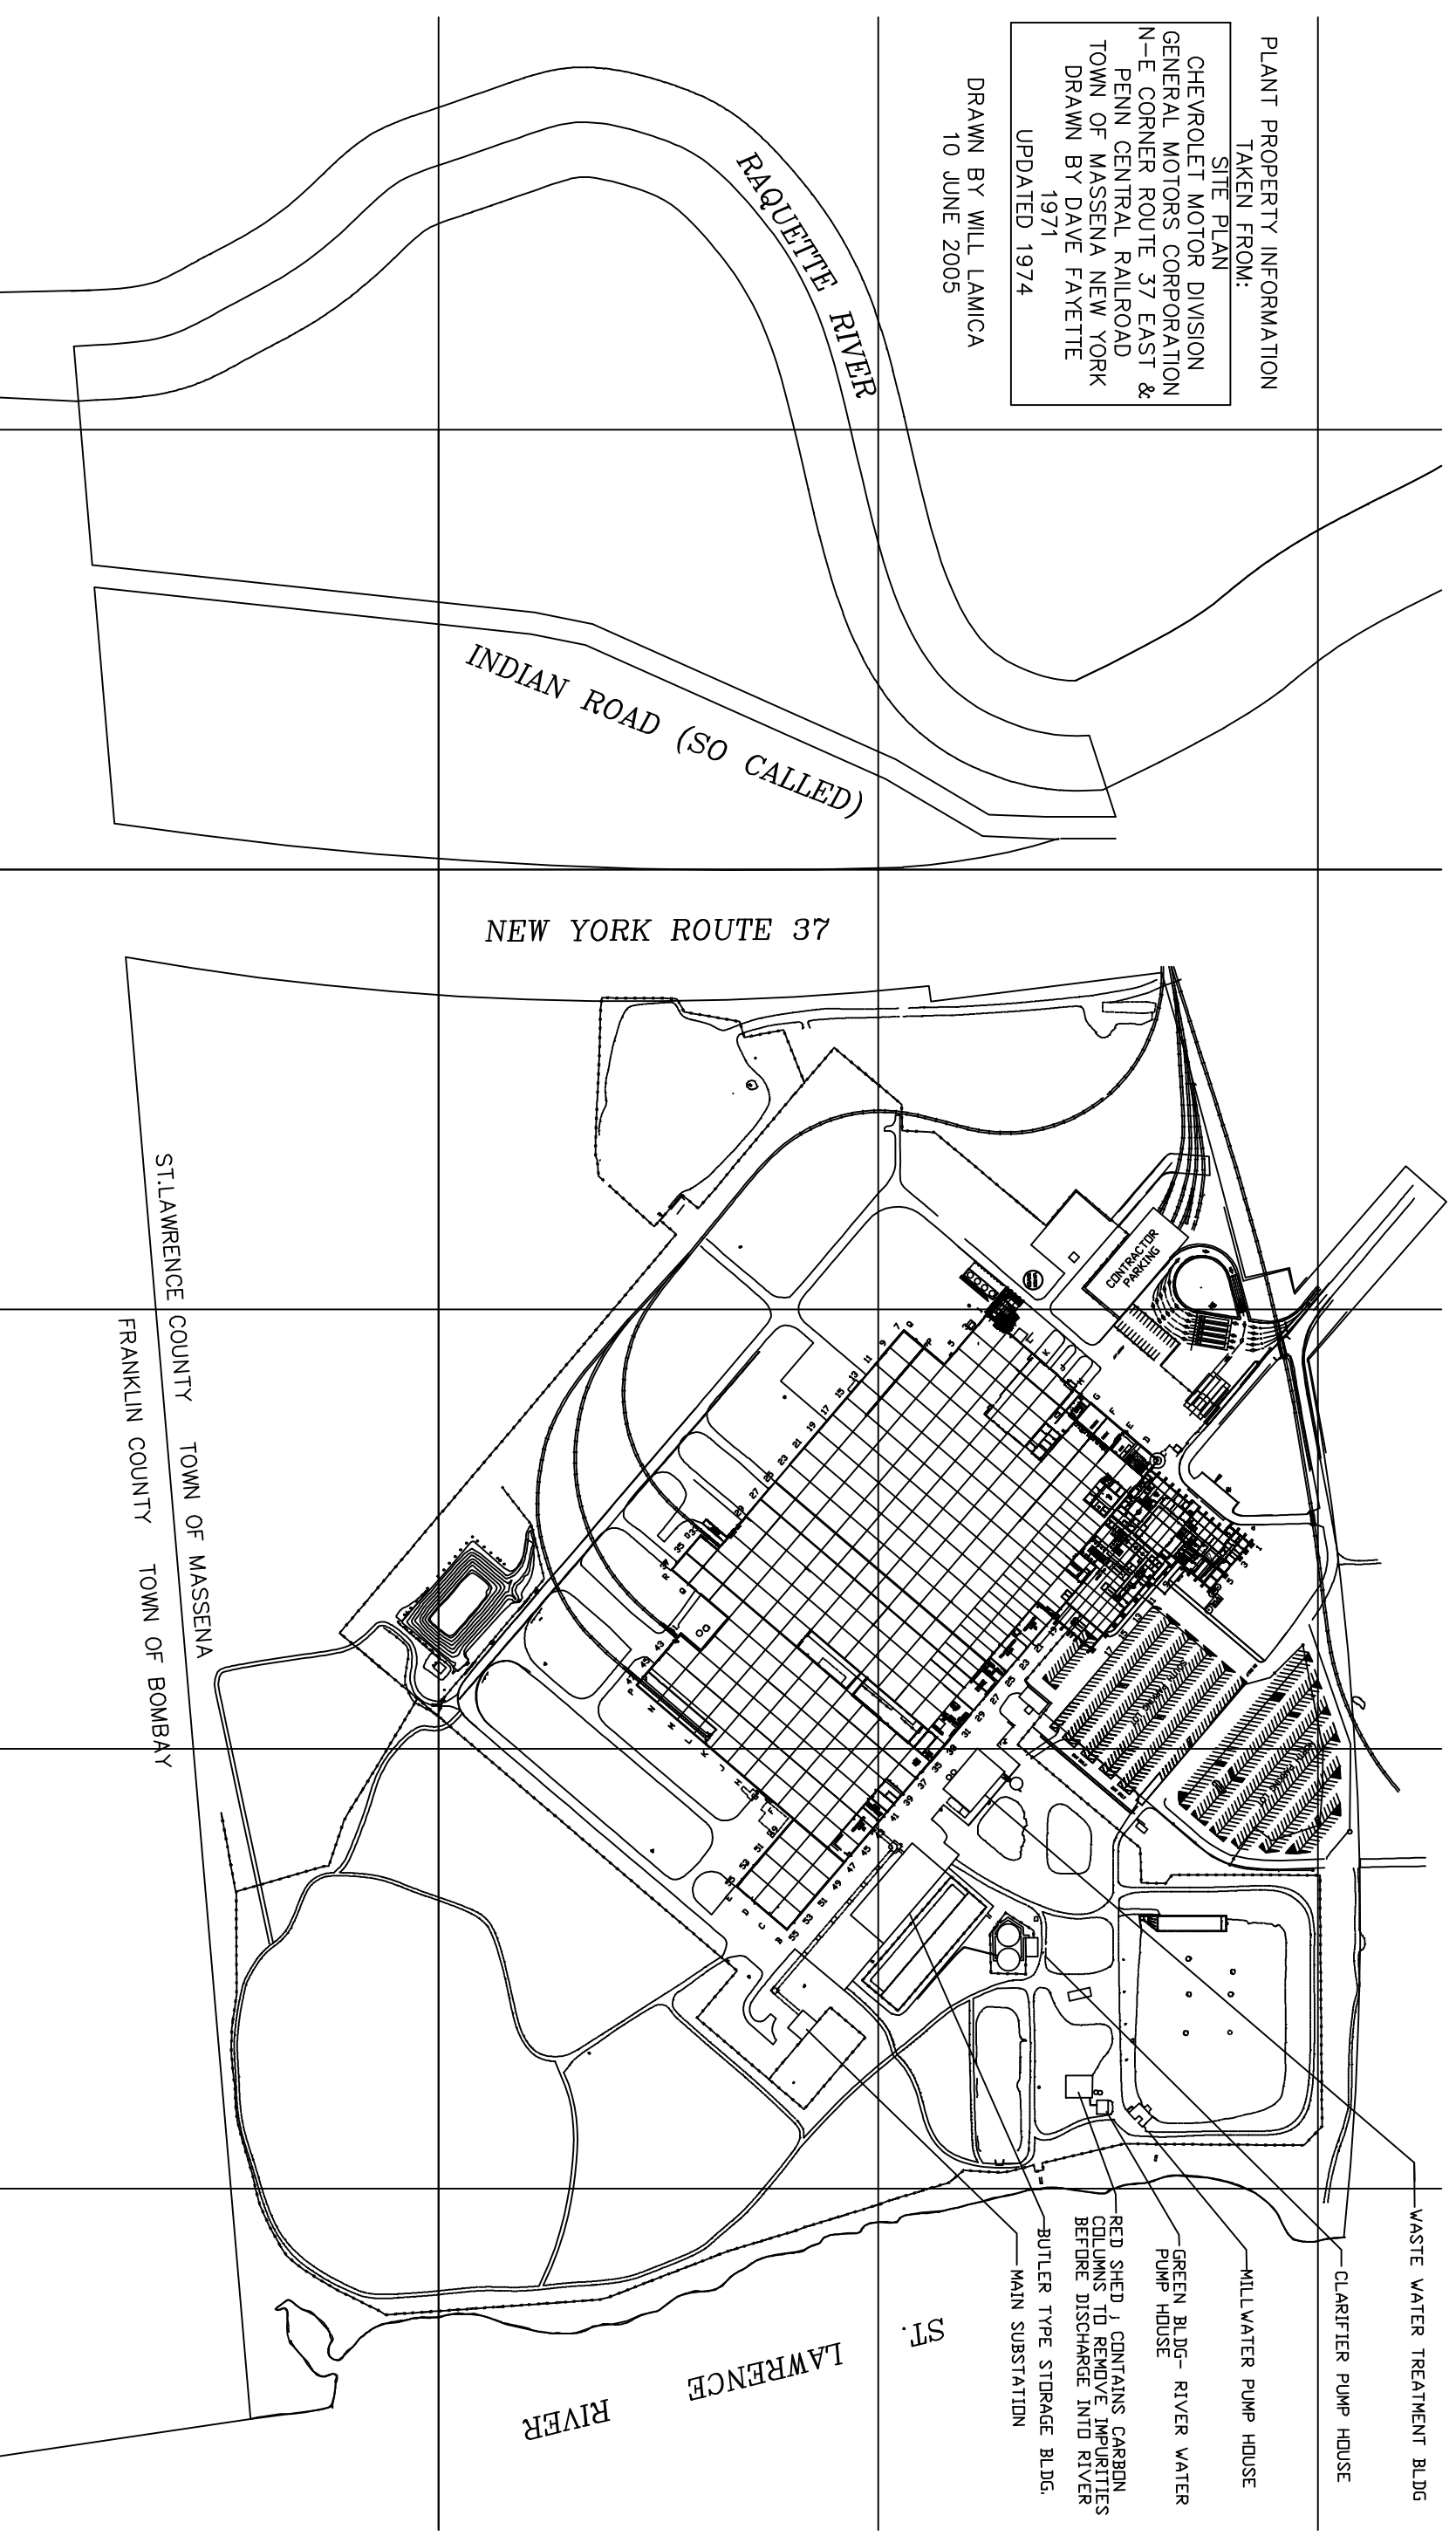

WASTE WATER TREATMENT BLDG

CLARIFIER PUMP HOUSE

MILLWATER PUMP HOUSE

GREEN BLDG- RIVER WATER PUMP HOUSE

RED SHED, J CONTAINS CARBON COLUMNS TO REMOVE IMPURITIES BEFORE DISCHARGE INTO RIVER

BUTLER TYPE STORAGE BLDG, MAIN SUBSTATION

ST

LAWRENCE RIVER

RAQUETTE RIVER

INDIAN ROAD (SO CALLED)

NEW YORK ROUTE 37

ST. LAWRENCE COUNTY

TOWN OF MASSENA

FRANKLIN COUNTY

TOWN OF BOMBAY

10 JUNE 2005 BY WILL LAMICA
PROPERTY BOUNDARIES.DWG